


**LEGEND OF SYMBOLS**

- H.D. ● FIRE DETECTION DEVICE
- P.S. ■ FIRE ALARM PULL STATION
- FIRE ALARM HORN
- F.E. ● FIRE EXTINGUISHER
- ⊗ ILLUMINATED EXIT SIGN
- ☒ EMERGENCY LIGHT FIXTURE
- \* SPRINKLER HEAD
- ▶ FIRE ALARM HORN / STROBE
- FACP FIRE ALARM ANNUCIATOR CONTROL PANEL

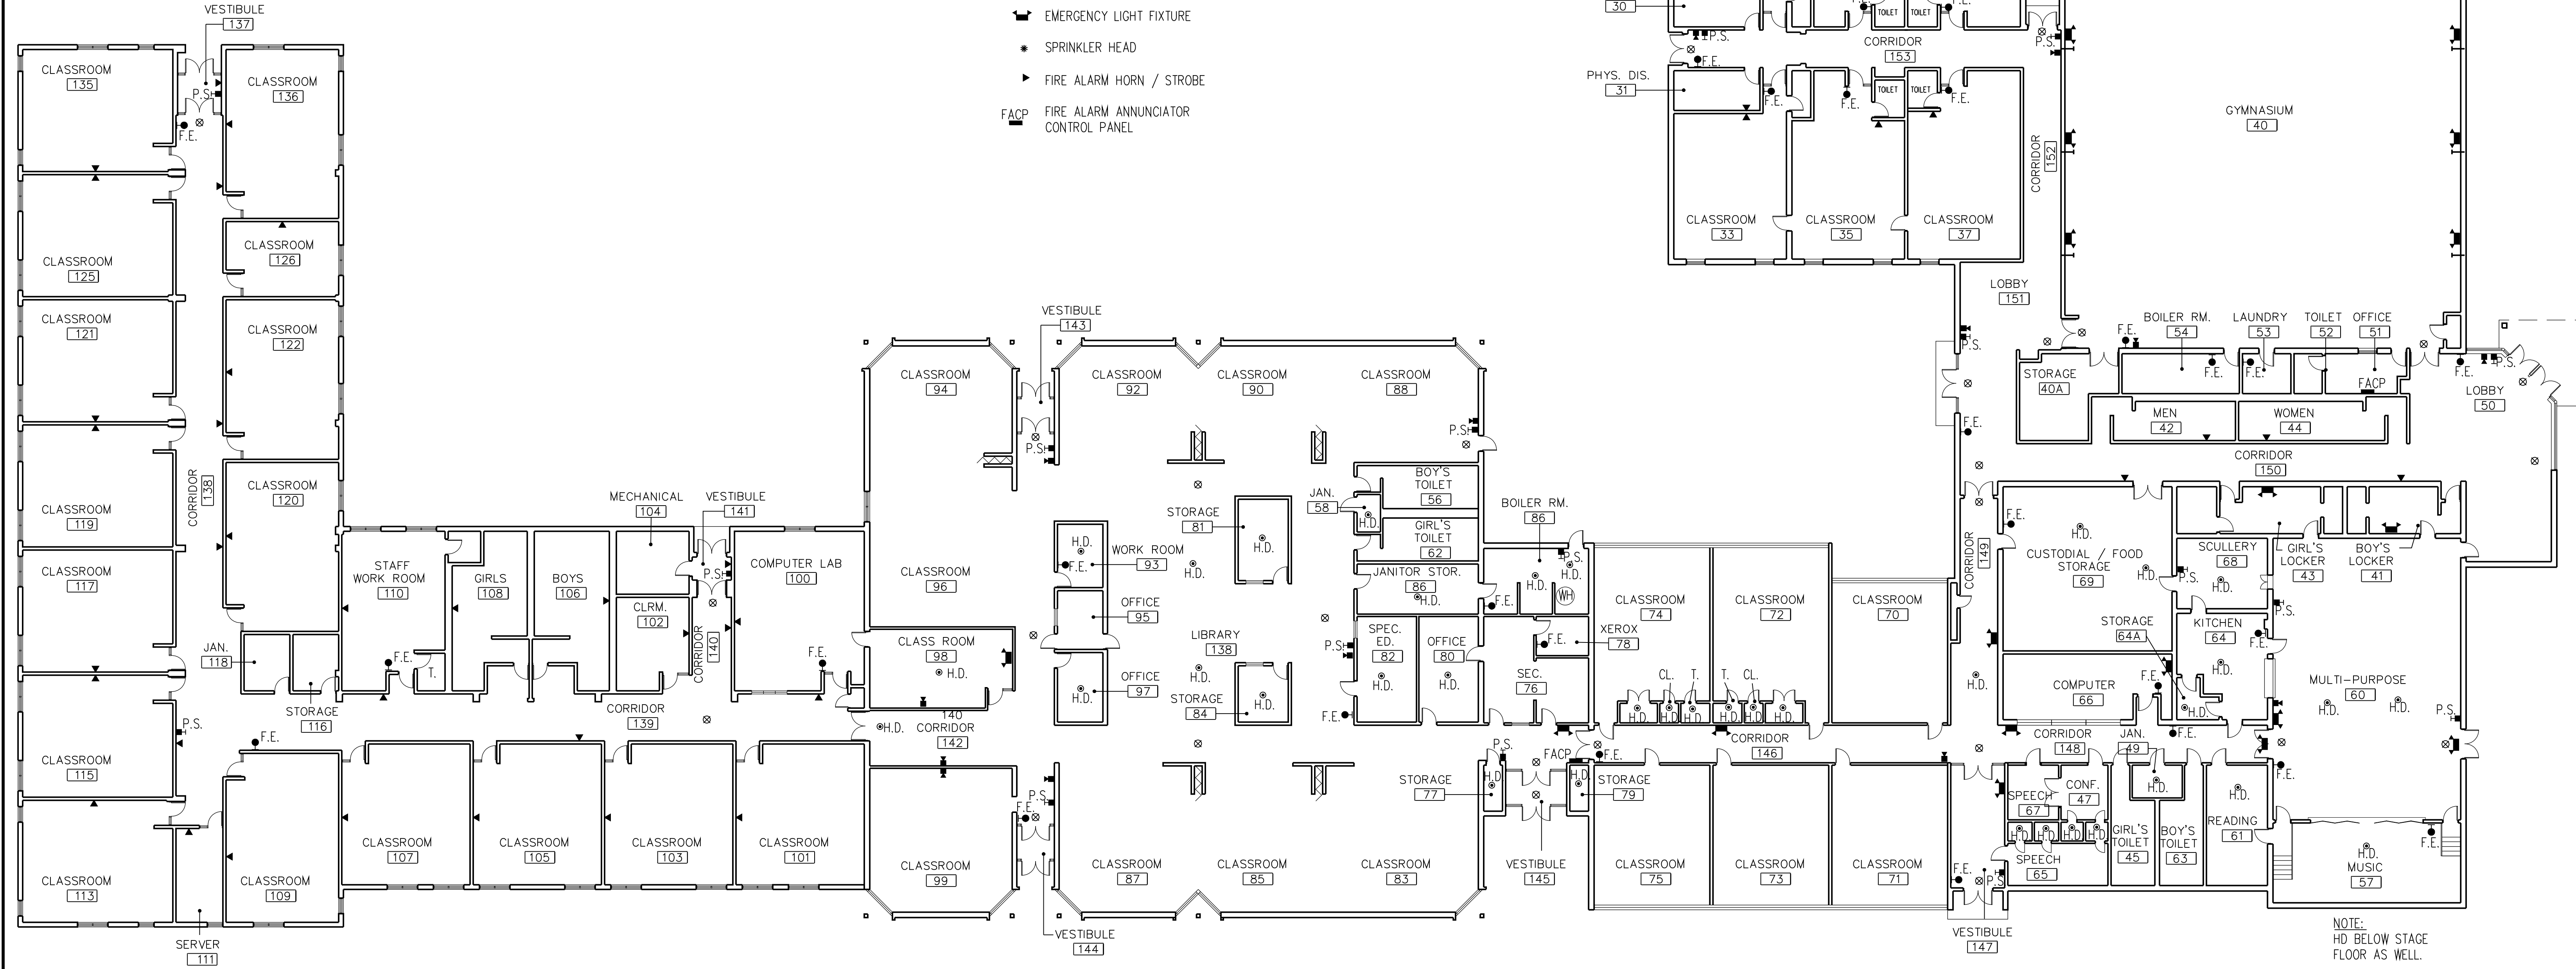

**FIRST FLOOR PLAN - MONROE ELEMENTARY SCHOOL**  
 SCALE: 1/16" = 1'-0"

NOTE:  
 ROOM NUMBERS REVISED BY SCHOOL DISTRICT, FEBRUARY 2017.

NOTE: CONTRACTOR SHALL OBTAIN AND VERIFY ALL DIMENSIONS AND CONDITIONS AT JOB SITE AND BE FULLY RESPONSIBLE FOR SAME | © 2015 ALLIED DESIGN CONSULTANTS, INC. ALL RIGHTS RESERVED

DRAWN RLH	APPROVED TRH	PLOT SCALE 12"=1'-0"
--------------	-----------------	----------------------------

**ALLIED DESIGN CONSULTANTS, INC.**  
 405 1/2 South Sixth Street  
 Springfield, Illinois 62701  
 (217) 522-3355 FAX:(217) 522-5570 alliedsn@fdgi.net  
**Architecture · Design · Planning**  
 STATE OF ILLINOIS PROFESSIONAL DESIGN FIRM #184-000195

HEALTH / LIFE SAFETY SURVEY REFERENCE PLANS  
**HEALTH / LIFE SAFETY SURVEY**  
**MONROE ELEMENTARY SCHOOL**  
 CASEY - WESTFIELD C.U.S.D. NO. C-4  
 CASEY, CLARK COUNTY, ILLINOIS

PROJECT NO. 2015-15
DATE NOVEMBER, 2015
SHEET NO. <b>A-1</b>
OF 1 SHEETS